

INTERIORS:  
K & CO LLC  
12-16 VESTRY ST. 7TH FLOOR  
NEW YORK, NY, 10013  
T 212 335 0950

ARCHITECTURE:  
STONEHILL & TAYLOR ARCHITECTS, P.C.  
31 WEST 27TH STREET  
NEW YORK, NEW YORK 10001  
T 212 226 8898

MEP:  
WSP FLACK + KURTZ  
512 SEVENTH AVENUE  
NEW YORK, NY 10018  
T 212 532 9600

CONSULTANT:  
SAM TELL COMPANIES  
1375 BROADWAY SUITE 502  
NEW YORK, NY 10018  
T 212 224 0008 X 1213

CONSULTANT:  
BRIAN ORTNER LIGHTING DESIGN  
227 WEST 29TH STREET 8TH FLOOR  
NEW YORK, NY 10001  
T 212 674 6500 X 107

COPYRIGHT © 2016 K & CO, LLC

NOT FOR CONSTRUCTION  
FOR COORDINATION PURPOSES ONLY

PROJECT:  
**CROWNE PLAZA LOBBY**  
320 WEST 36TH STREET  
NEW YORK, NY 10018

PROJECT NO.: 1030  
DRAWING TITLE:  
**4TH FLOOR PLAN**

SEAL & SIGNATURE:

DATE: 2/9/17

PROJ. NO.: 1030

DRAWN BY: MDM



CHECKED BY: KLN

DWG NO.:

**ID-157.00**

PAGE NO.:

W 36 STREET

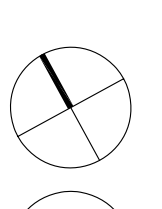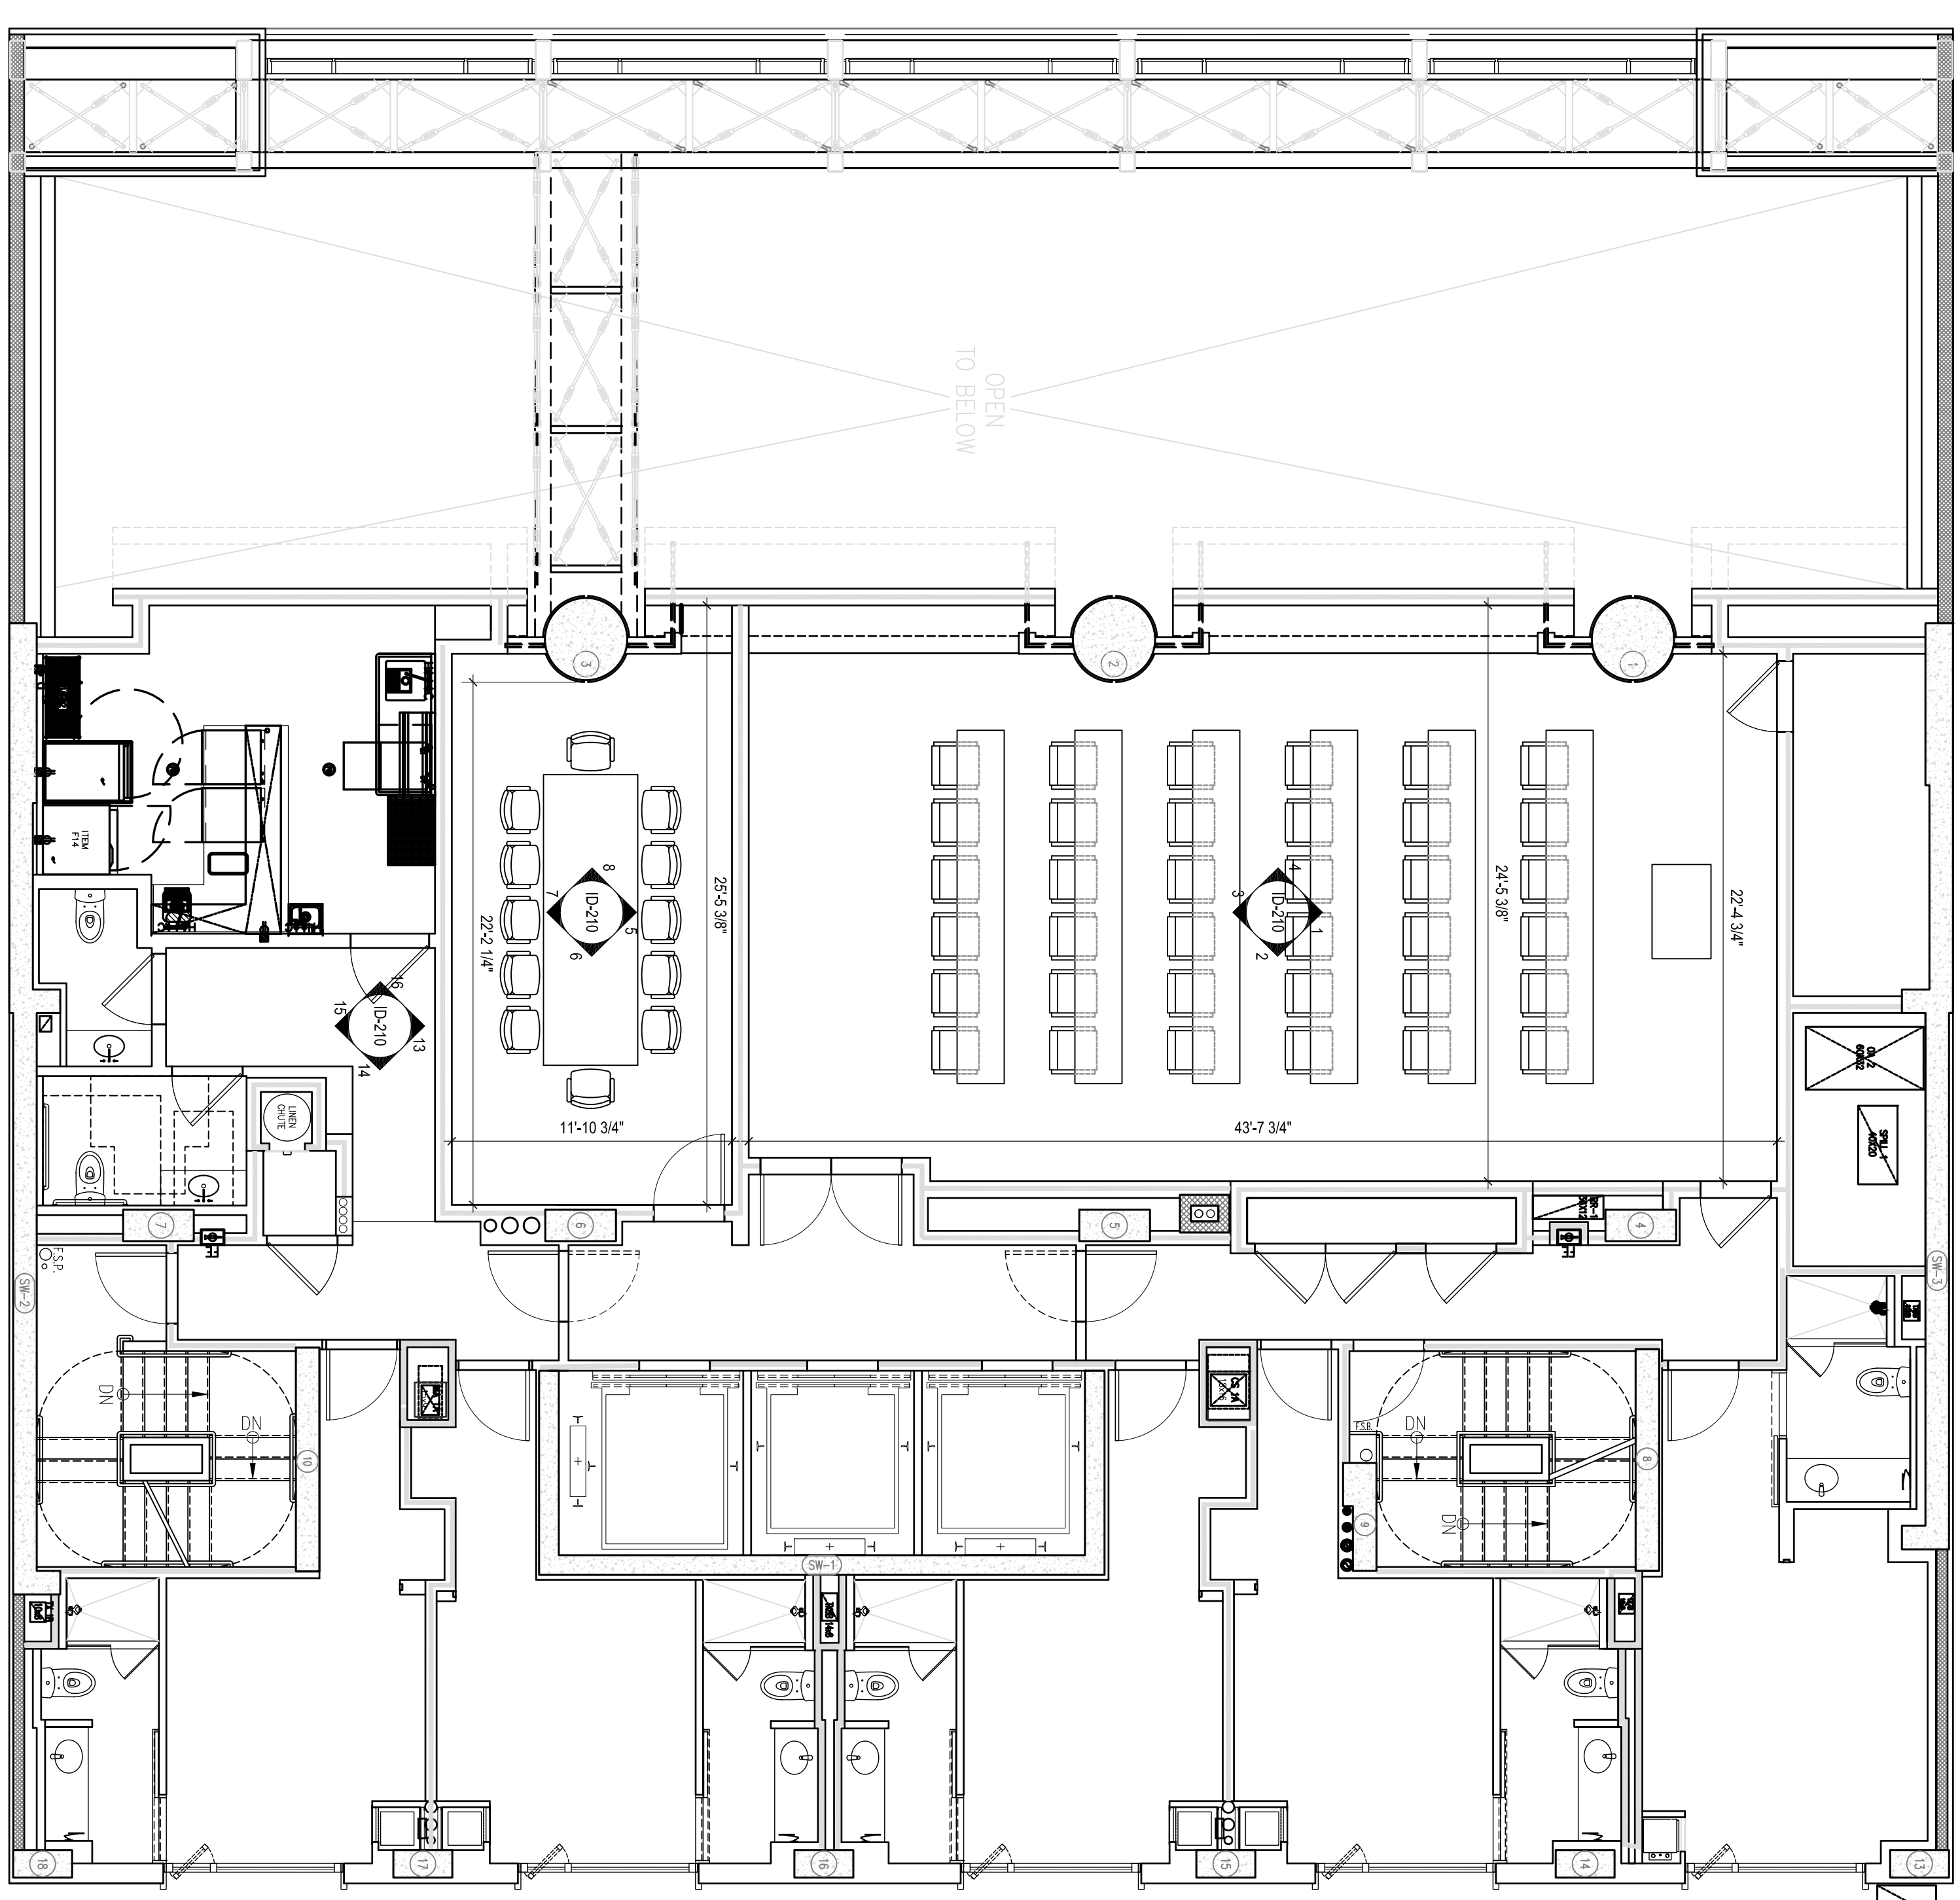

1

4TH FLOOR PLAN  
SCALE: 3/8" = 1'-0"